




A ELECTRICAL SITE PLAN-BLDG 46  
 E4E4 SCALE: 1/16"=1'-0"

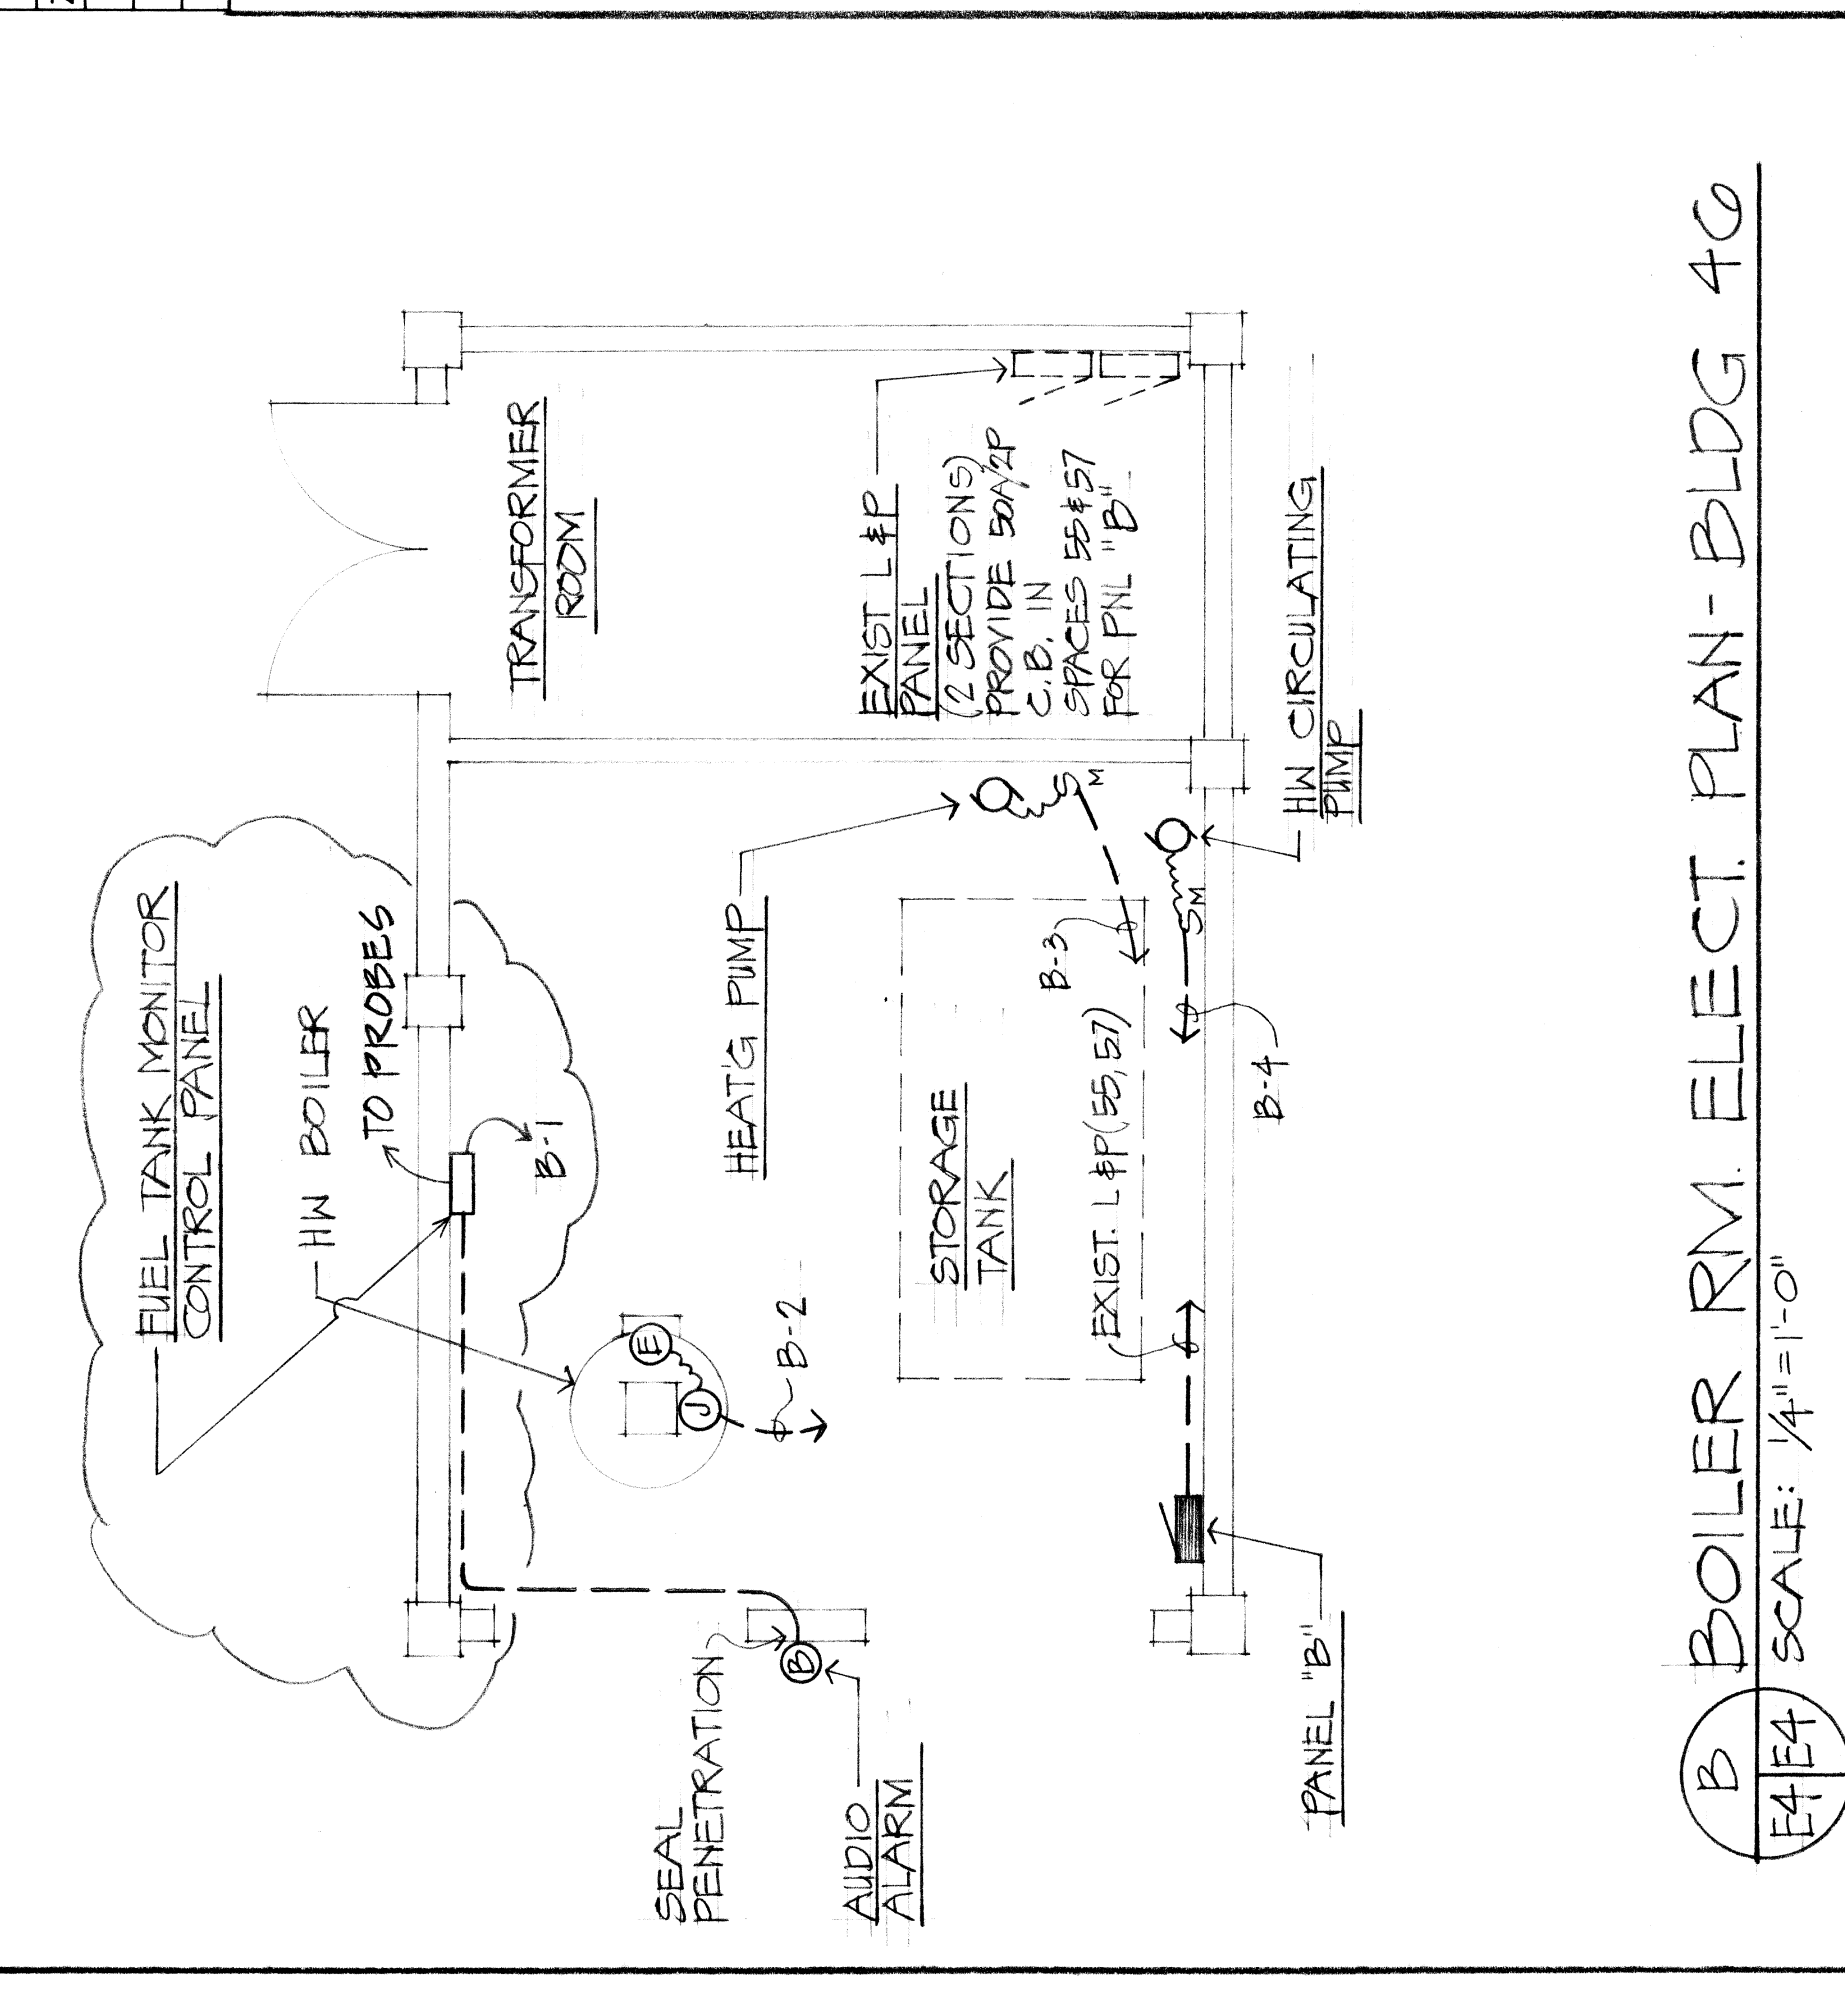

B BOILER RM. ELECT. PLAN-BLDG 46  
 E4E4 SCALE: 1/4"=1'-0"

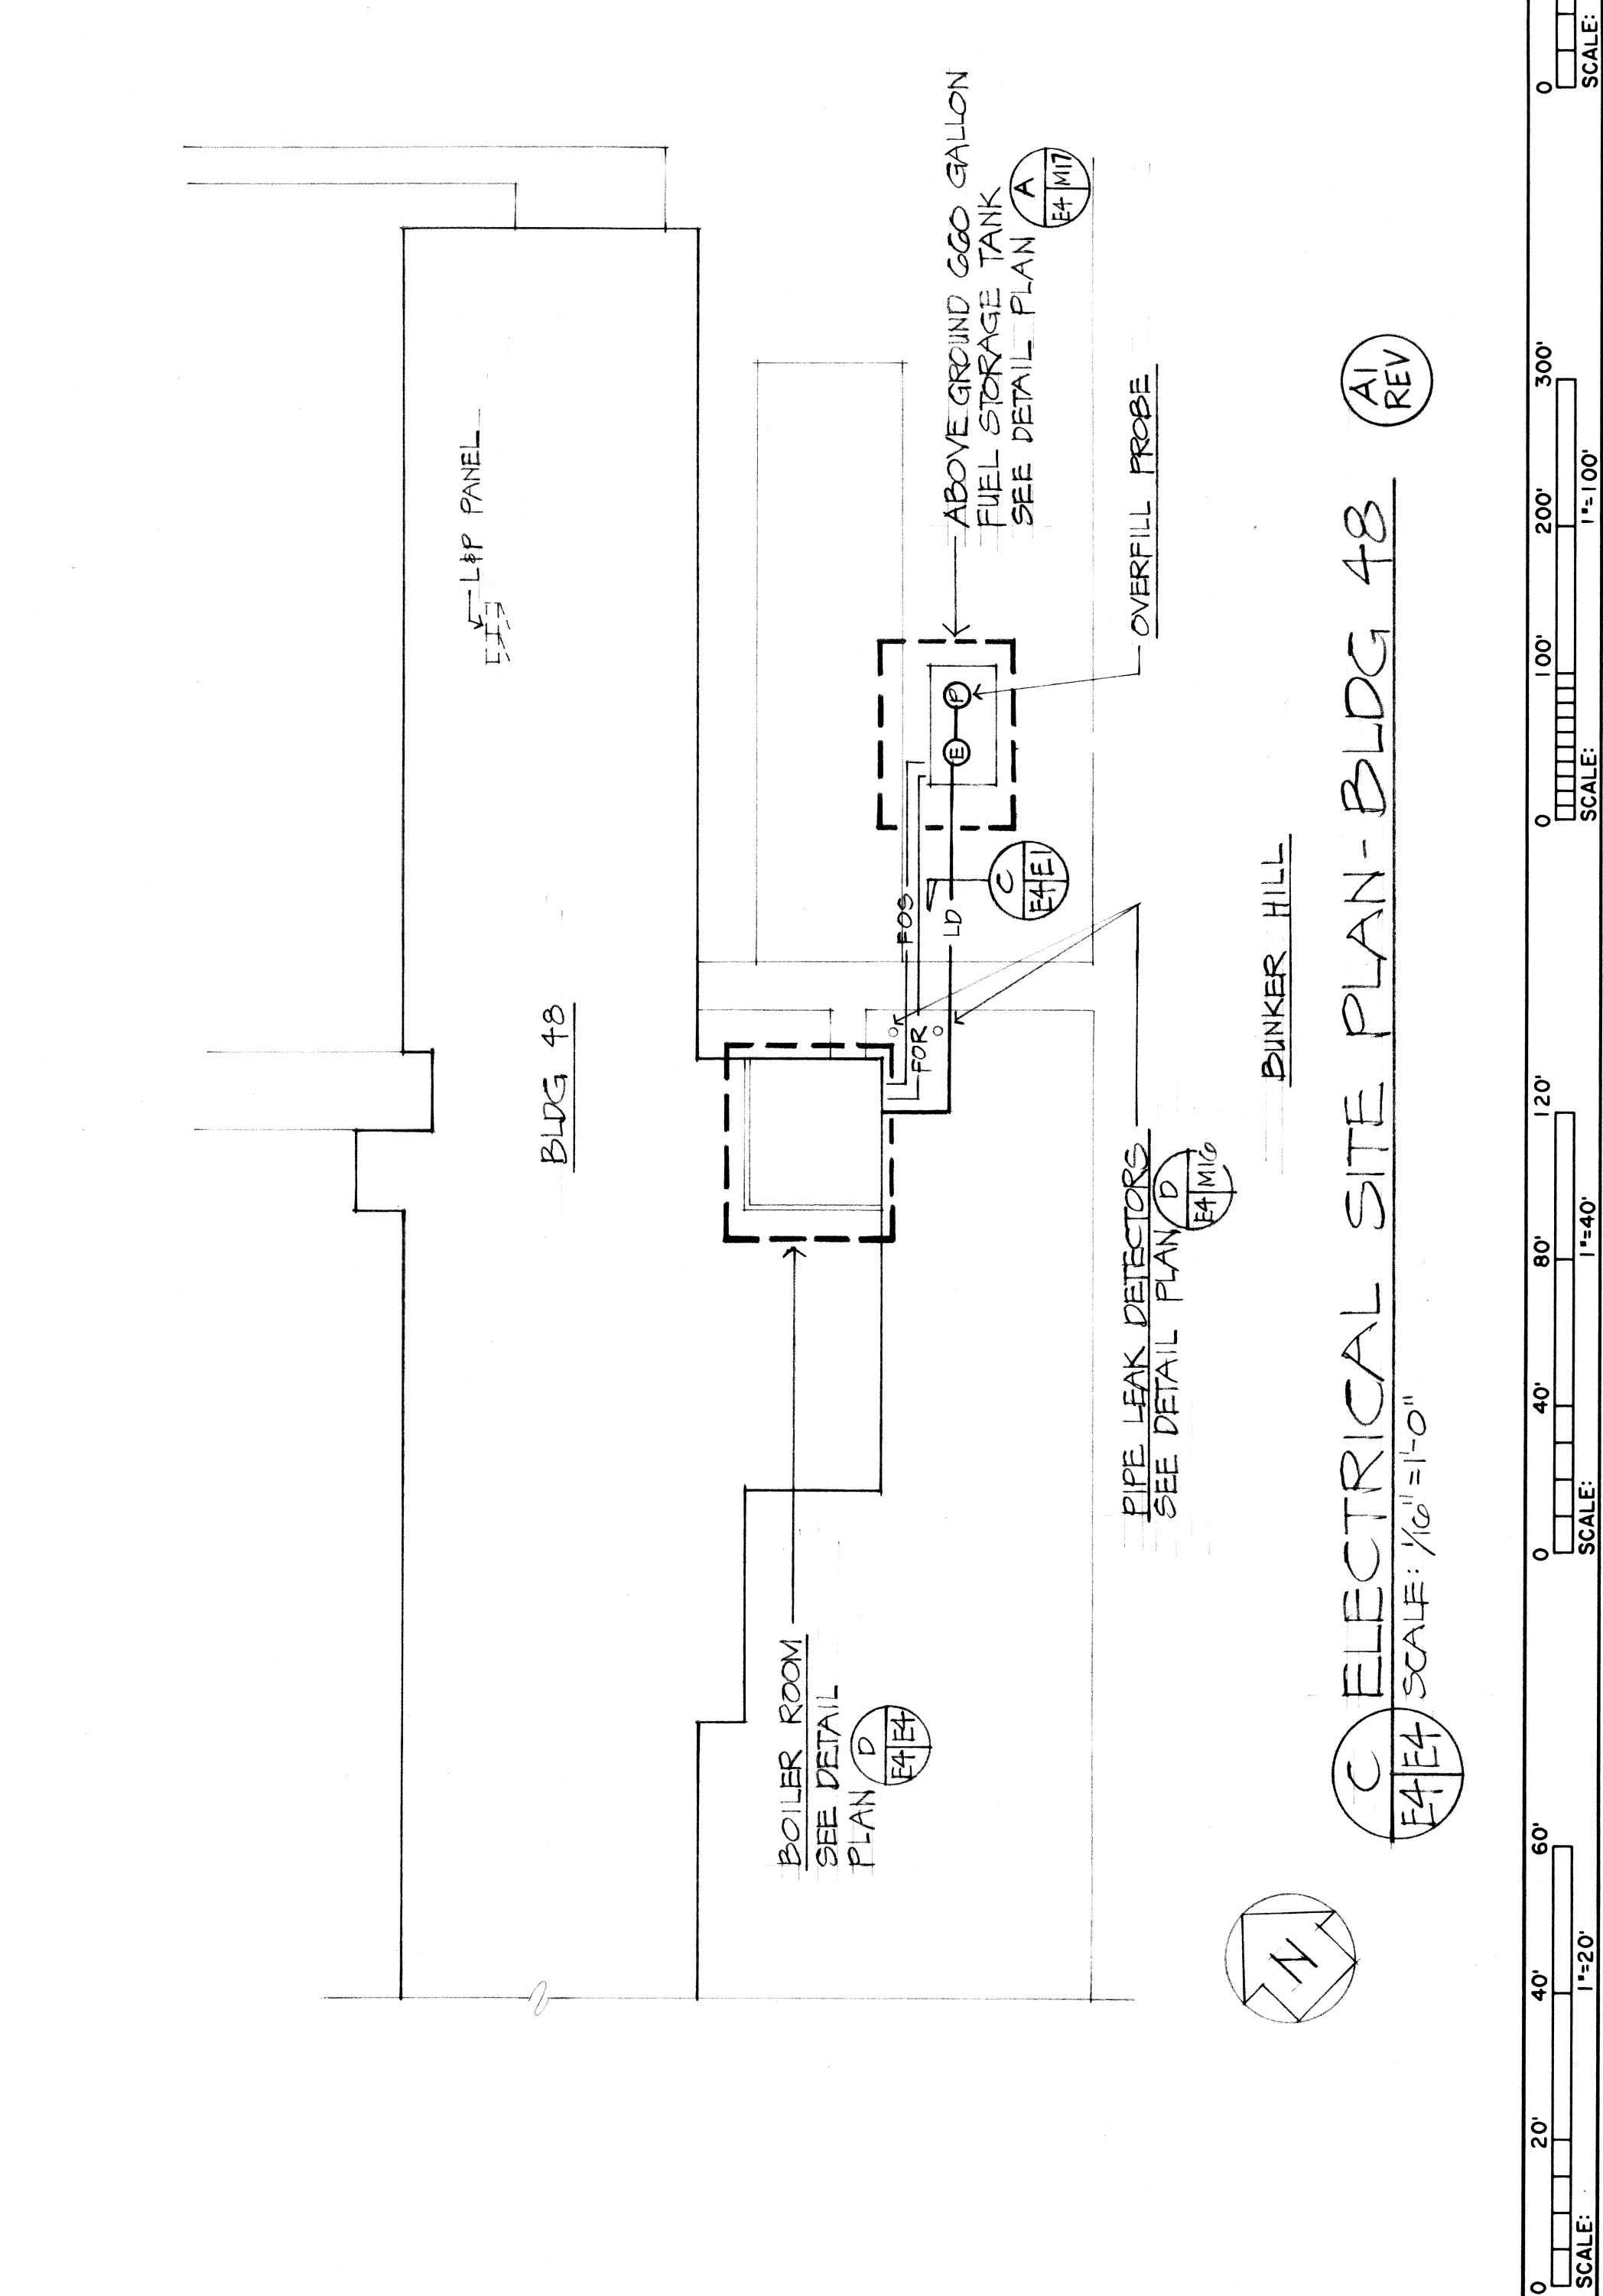

C ELECTRICAL SITE PLAN-BLDG 48  
 E4E4 SCALE: 1/16"=1'-0"

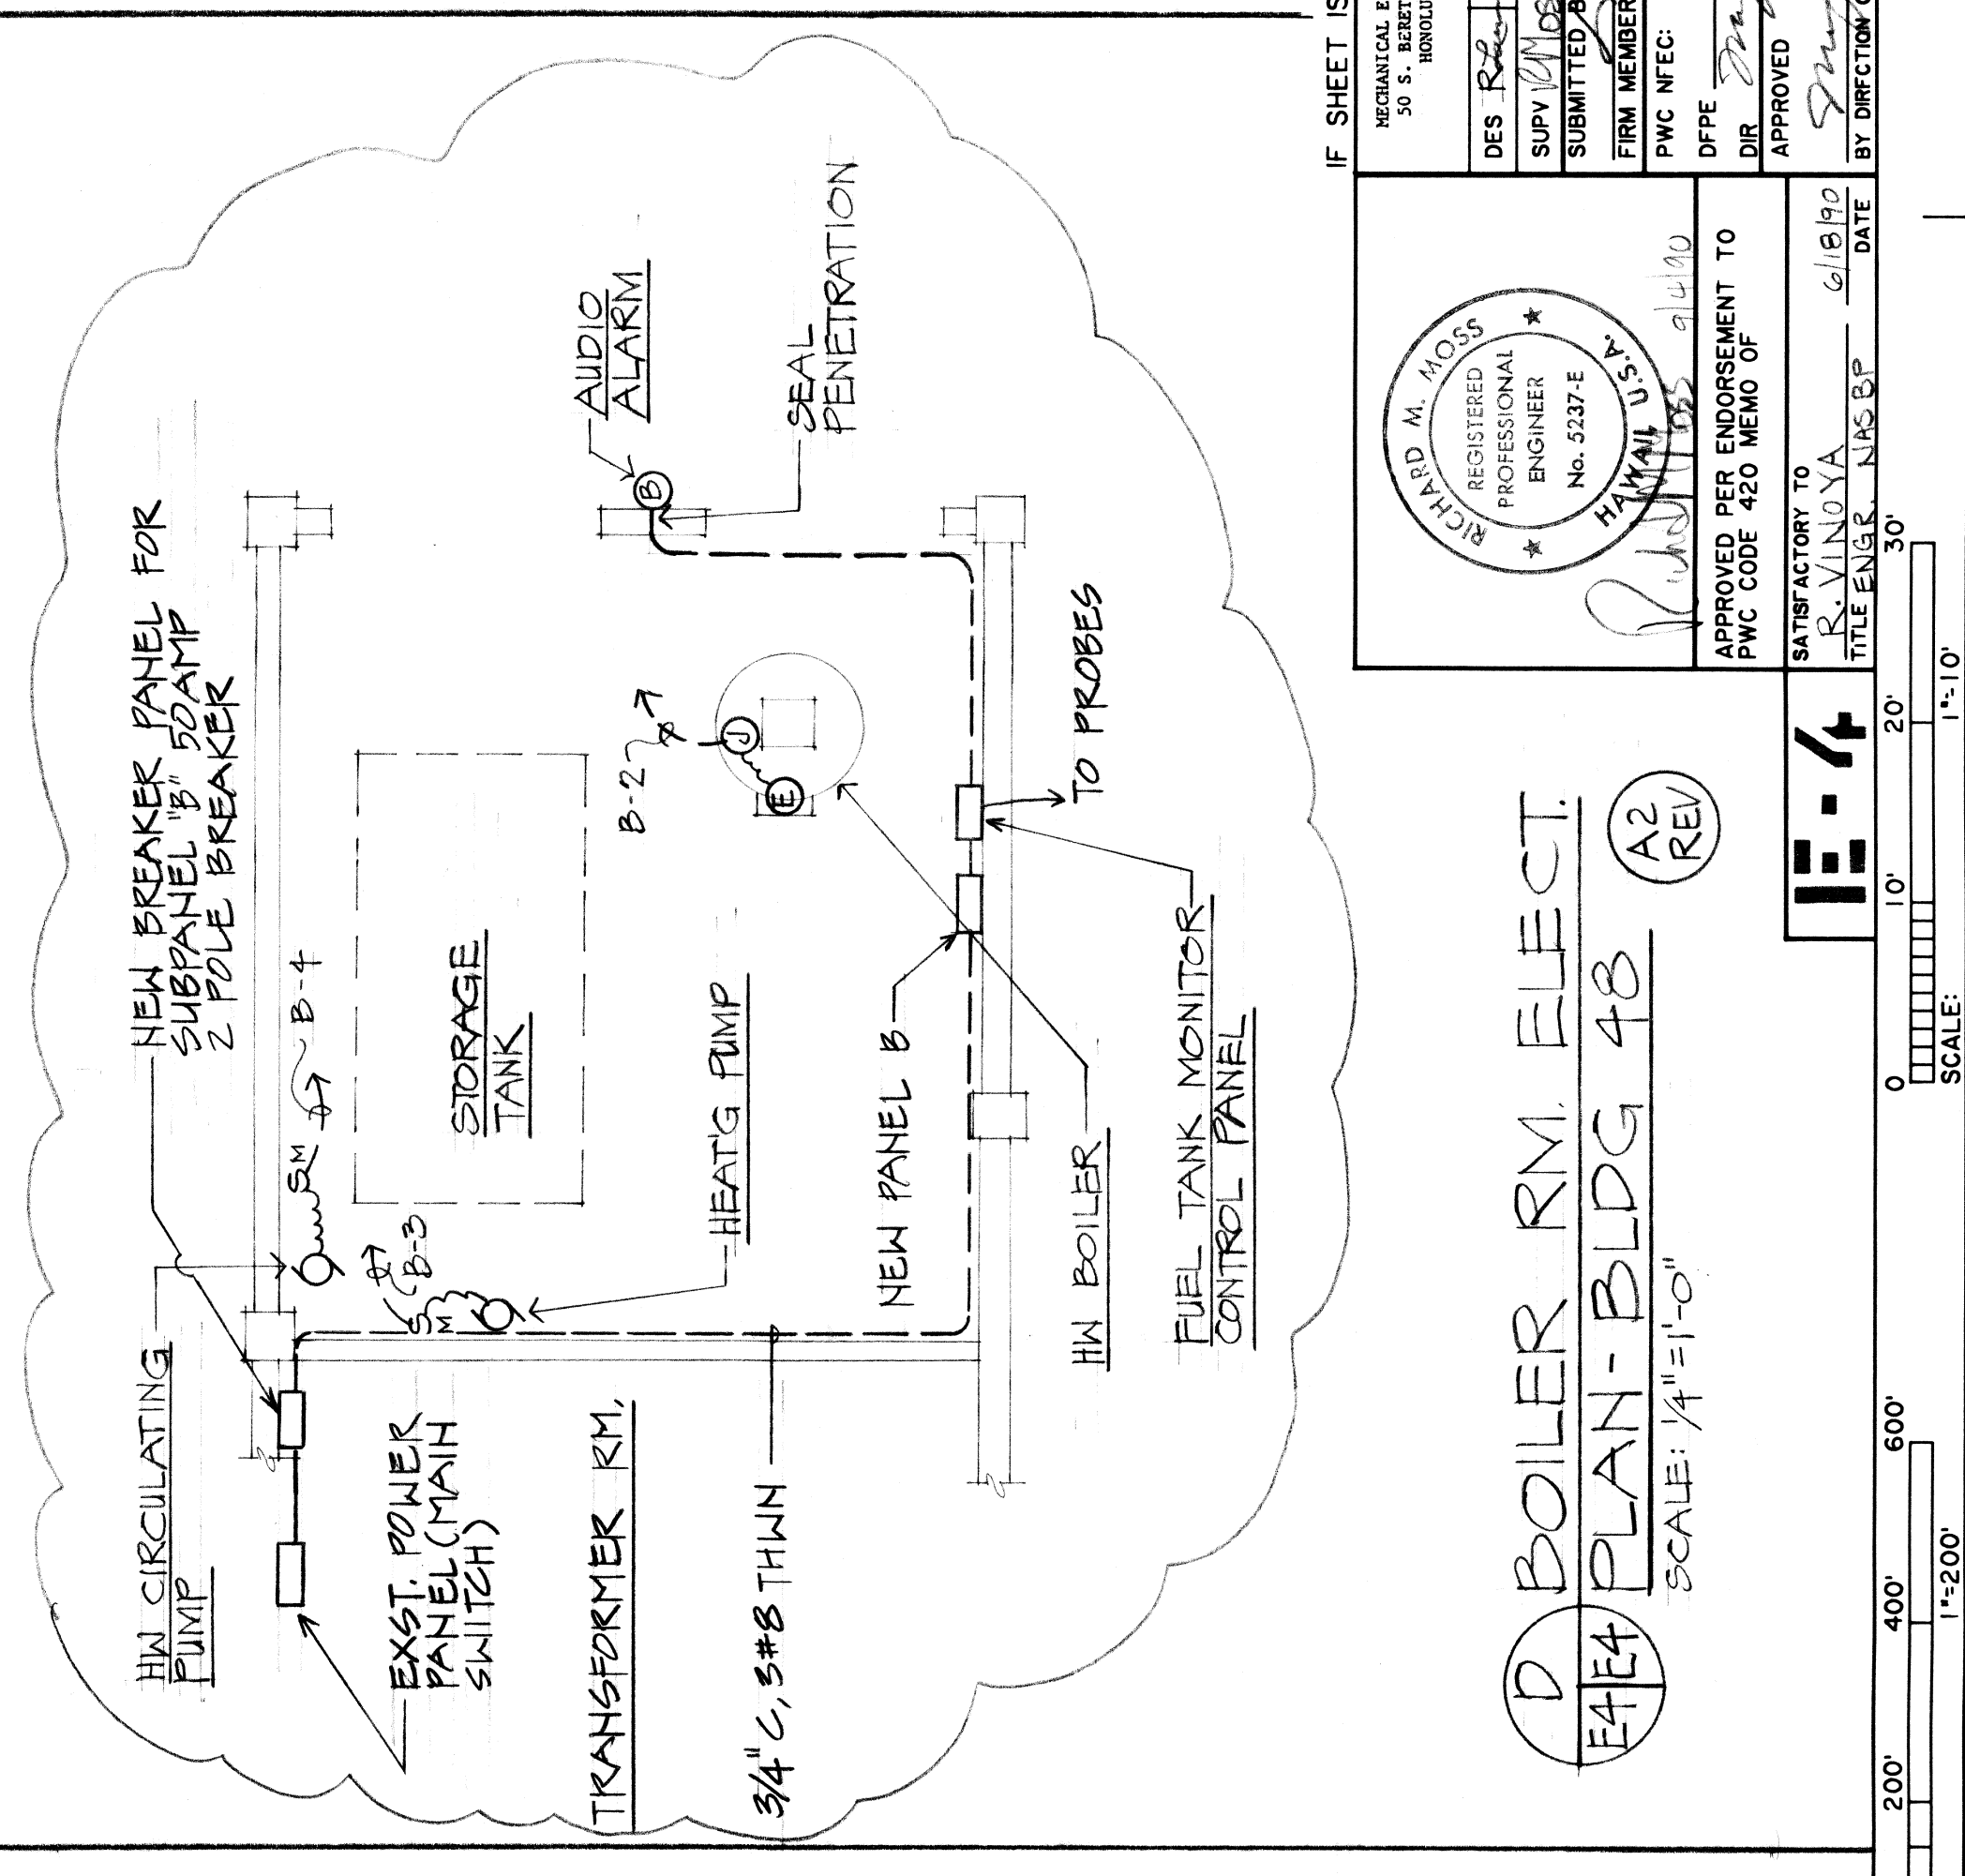

D BOILER RM. ELECT. PLAN-BLDG 48  
 E4E4 SCALE: 1/4"=1'-0"

ZONE LTR	DESCRIPTION	DATE	APPROVED
A	ADDED "ELECTRICAL SITE PLAN-BLDG 46"	12/91	32
B	ADDED "BOILER RM. ELECT. PLAN-BLDG 46"		
	AS BUILT CONDITION SHOWN	5/12/93	

REVISIONS	DESCRIPTION	DATE	APPROVED
A	ADDED "ELECTRICAL SITE PLAN-BLDG 46"	12/91	32
B	ADDED "BOILER RM. ELECT. PLAN-BLDG 46"		
	AS BUILT CONDITION SHOWN	5/12/93	

IF SHEET IS LESS THAN 22" X 34" IT IS A REDUCED PRINT. SCALE REDUCED ACCORDINGLY.

DEPARTMENT OF THE NAVY  
 NAVAL FACILITIES ENGINEERING COMMAND  
 PUBLIC WORKS CENTER  
 PEARL HARBOR, HAWAII

NAS 2P  
 BARBERS POINT, HI  
 VARIOUS BUILDINGS  
 REPLACE BOILERS, HOT WATER STORAGE TANKS & FUEL STORAGE TANKS  
 ELECT. PLANS FOR BLDGS 46

DES: [Signature] DR: [Signature] CH ENG: [Signature] DATE: 9-12-90  
 SUBMITTED: [Signature] FIRM MEMBER: [Signature] RVD TO: [Signature] PDE: [Signature]  
 PWC NTC: [Signature] DIR: [Signature] APPROVED: [Signature] DATE: [Signature]  
 APPROVED PER ENDORSEMENT TO PWC CODE 460 MEMO OF: [Signature] DATE: [Signature]

RICHARD M. MOSS  
 REGISTERED PROFESSIONAL ENGINEER  
 No. 5337 E  
 HAWAII, U.S.A.  
 APPROVED PER ENDORSEMENT TO PWC CODE 460 MEMO OF: [Signature] DATE: [Signature]

SATISFACTORY TO: [Signature] DATE: [Signature]  
 TITLE: [Signature]  
 BY: [Signature] DATE: [Signature]

SIZE: CODE IDENT NO: 7480038  
 NAVFAC DRAWING NO: 80091  
 CONSTR CONTR NO: N62471-10-C-2925  
 SPEC: 14-90-2925 SHEET 24 OF 27

SCALE: AS NOTED  
 WR NO: 10911